


Statistics							
Description	Symbol	Avg	Max	Min	Max/Min	Avg/Min	Avg/Max
PARKING LOT - NORTH	X	4.0 fc	15.9 fc	0.5 fc	31.8:1	8.0:1	0.3:1
PARKING LOT - SOUTH	X	3.8 fc	14.3 fc	0.7 fc	20.4:1	5.4:1	0.3:1
Pedestrian Walkway	X	2.5 fc	7.2 fc	0.5 fc	14.4:1	5.0:1	0.3:1
Roadway	X	3.6 fc	15.8 fc	0.5 fc	31.6:1	7.2:1	0.2:1

Luminaire Schedule											
Symbol	Label	QTY	Manufacturer	Catalog Number	Description	Lamp	Number Lamps	File Name	Lumens per Lamp	LLF	Wattage
	SP1	8	LUMEC	MPTK-70W64LED4K-R-LE3	MPTK WITH LE3 OPTICS, NW	LEDigne 64 NW LUXEON R	1	MPTK-70W64LED4K-R-LE3 (GRP001).IES	6325.576	0.95	72.2
	SP2	10	SIGNIFY CANADA LTD	MPTC-70W64LED4K-G3-LE4-HS	UrbanScape LED Post-Top (MPTC), 64 LEDs, 4000K CCT, TYPE LE4-HS OPTIC, House-side Shield	(4) LEDigne ABRAY(S) DRIVEN AT 350mA	1	MPTC-70W64LED4K-G3-LE4-HS.ies	5995.156	0.95	71
	SB	17	Landscape Forms	AP-012L5-03SF-LV1	Black formed aluminum housing, upper frosted plastic lens, no enclosure	12 white LEDs	1	LF_Ashbery_Path_Light_AP012L5.ies	841.2429	0.95	14.63

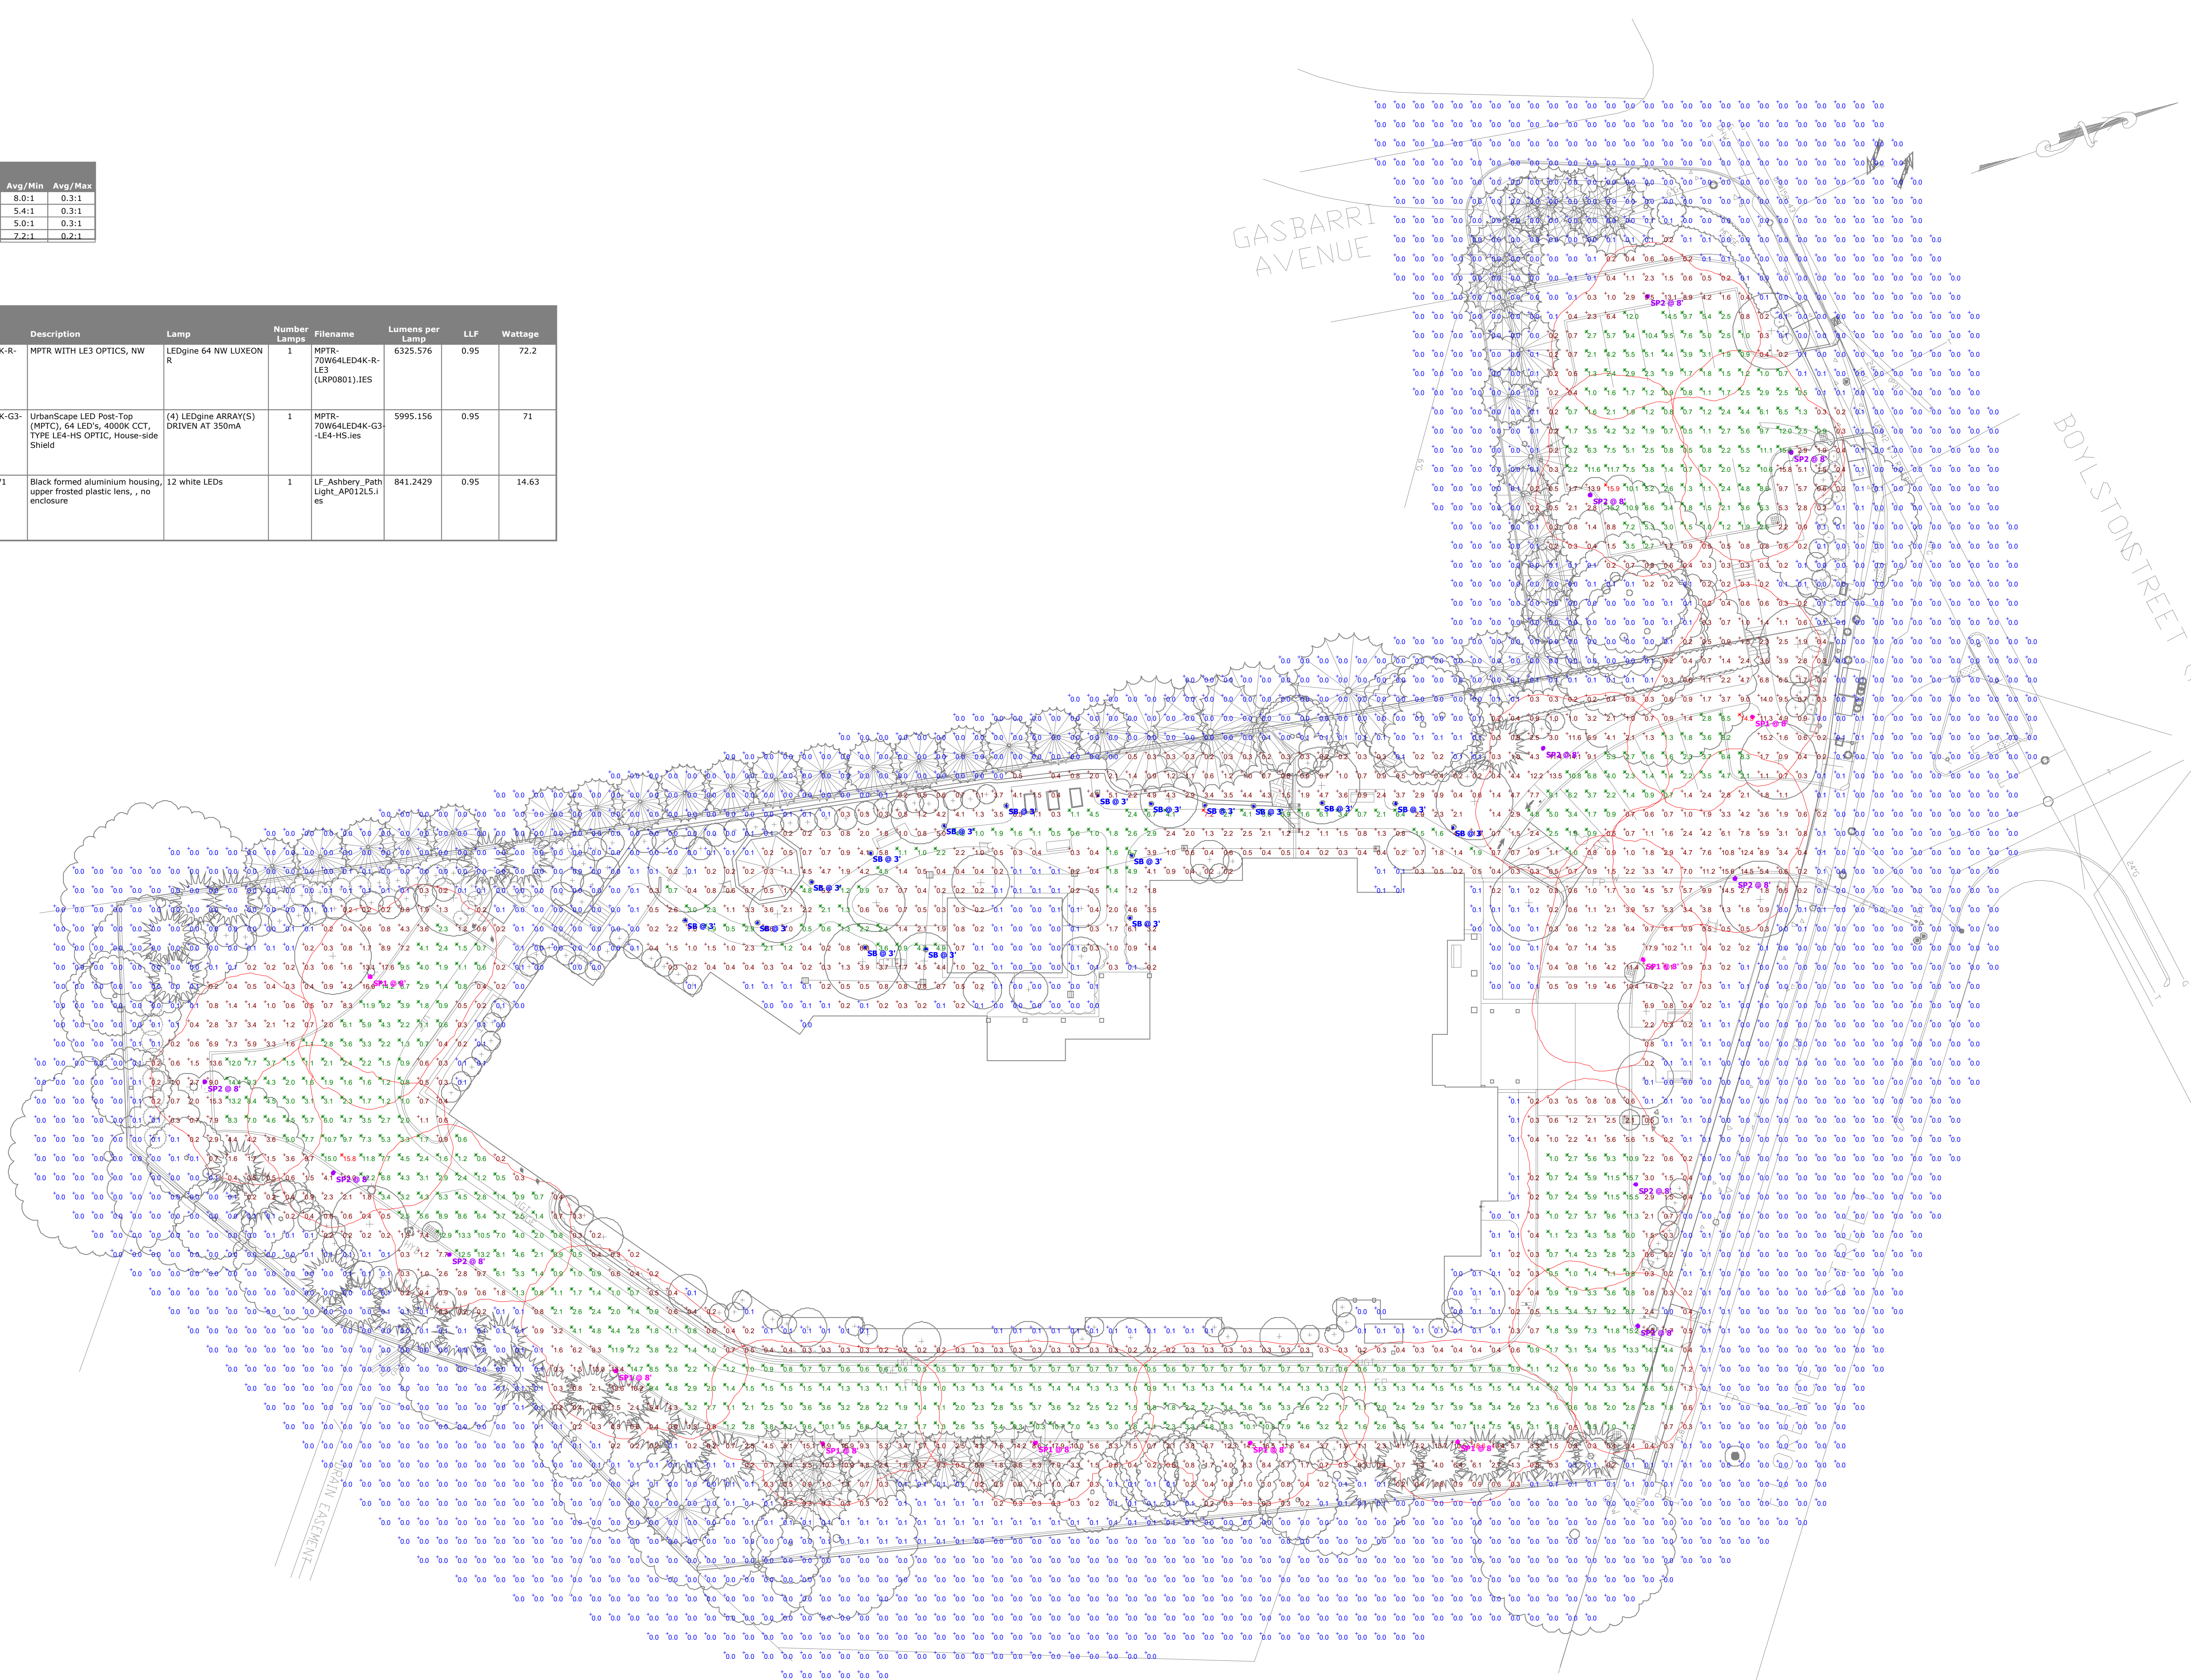

Plan View  
Scale = 1" = 20'