
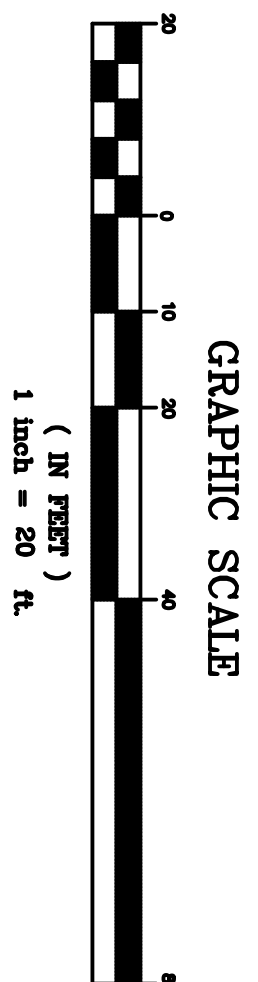
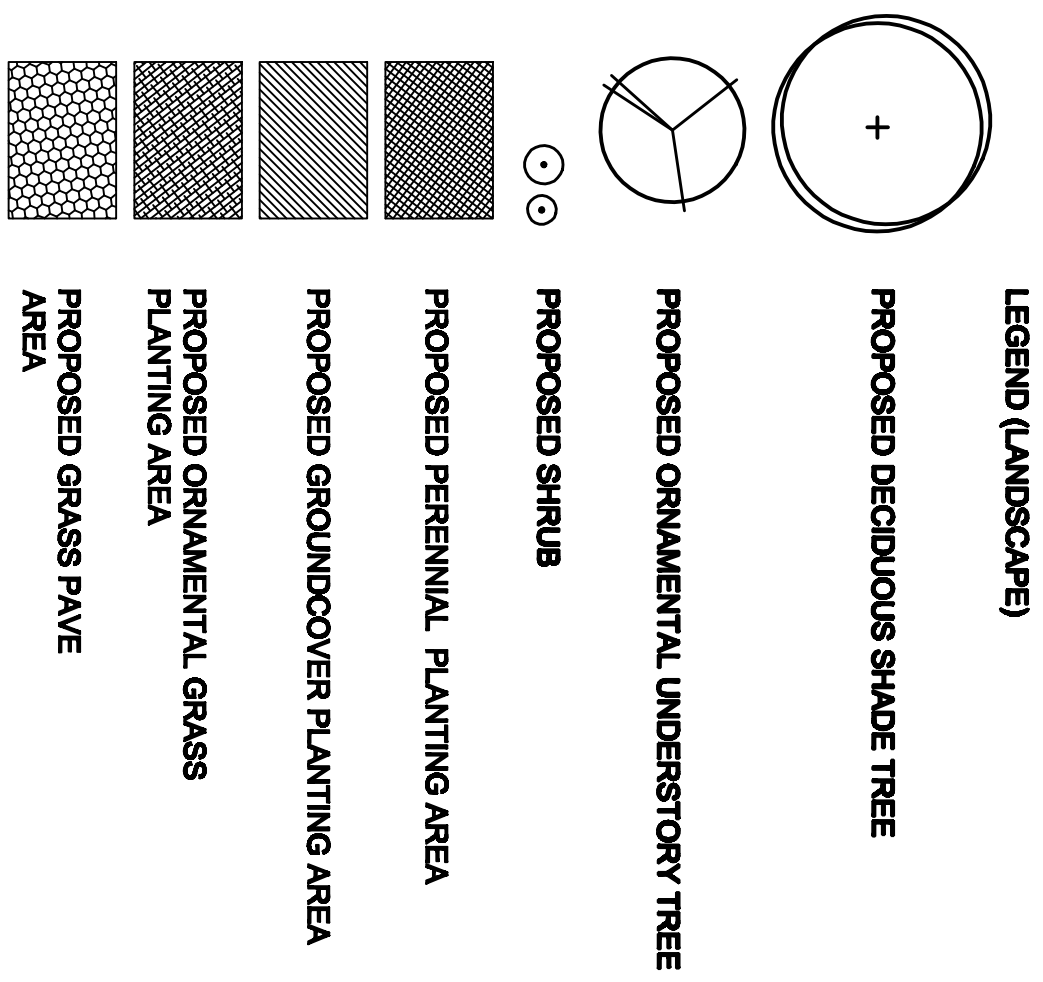


SYM.	QTY.	BOTANICAL NAME	COMMON NAME	SIZE	ROOT	COMMENTS
AR	1	DECIDUOUS SHADE TREE AGER RUBRUM OCTOBER GLORY*	OCTOBER GLORY RED MAPLE	2 1/2'-3' CAL.	B & B	SINGLE LEADER, FULL CROWN
OR	1	ORNAMENTAL UNDERSTORY TREE				
SHRUB	2	AMELANCHIER CANADENSIS	SHADBLOW SERVICEBERRY	7-8' HT.	B & B	MULTI-STEM; SINGLE LEADER, FULL CROWN
AA	8	ARONIA ARBURTICOLA 'BRILLIANTISSIMA'	BRILLIANT RED CHOKEBERRY	#7	CONT.	FULL, 30-36" HT.
CA	7	GLETRIA ALNIFOLIA 'HUMMINGBIRD'	'HUMMINGBIRD' SUMMERSWEET	#7	CONT.	FULL, 30-36" HT.
CS	19	CORNUS SERICEA 'KELSIEY'	'KELSEY' REDOSIER DOGWOOD	#3	CONT.	FULL, 24" HT.
FG	17	FOETHEGILLA GARDENII 'JANE PLATT'	'JANE PLATT' DWARF FOTHERGILLA	#3	CONT.	FULL, 24" HT.
HV	10	HAMAMELIS VIRGINIANA	COMMON WITCHHAZEL	#5	CONT.	FULL, 30" HT.
TM	74	TRAXUS X MEDIA 'HAYFIELD'	HAYFIELD YEW	24-30" HT.	B & B	FULL
VD	10	VIBURNUM DENTATUM CHICAGO LUSTRE	ARROWWOOD VIBURNUM	#7	B & B	FULL, 24" HT.
ORNA	28	ORNAMENTAL GRASS	NORTHERN SEA OATS	2 QT.	CONT.	24" O.C. SPACING
PV	50	PANICUM VIRGATUM 'SHERWOOD'	'SHERWOOD' RED SWITCH GRASS	2 QT.	CONT.	24" O.C. SPACING
GR	132	GROUNDCOVER AND PERENNIALS				
EP	82	EGHINACEA PURPUREA 'KIM'S KNEE HIGH'	'KIM'S KNEE HIGH' PURPLE CONEFLOWER	2 QT.	CONT.	15" O.C. SPACING
HS	82	HEMEROCALLIS 'STELLA DORC DAYLILY'	'STELLA DORC' DAYLILY	2 QT.	CONT.	15" O.C. SPACING
LS	1320	LIRIOPE SPICATA	CREeping LIRIOPE	2" POT	CONT.	12" O.C. SPACING

**PLANT SCHEDULE**

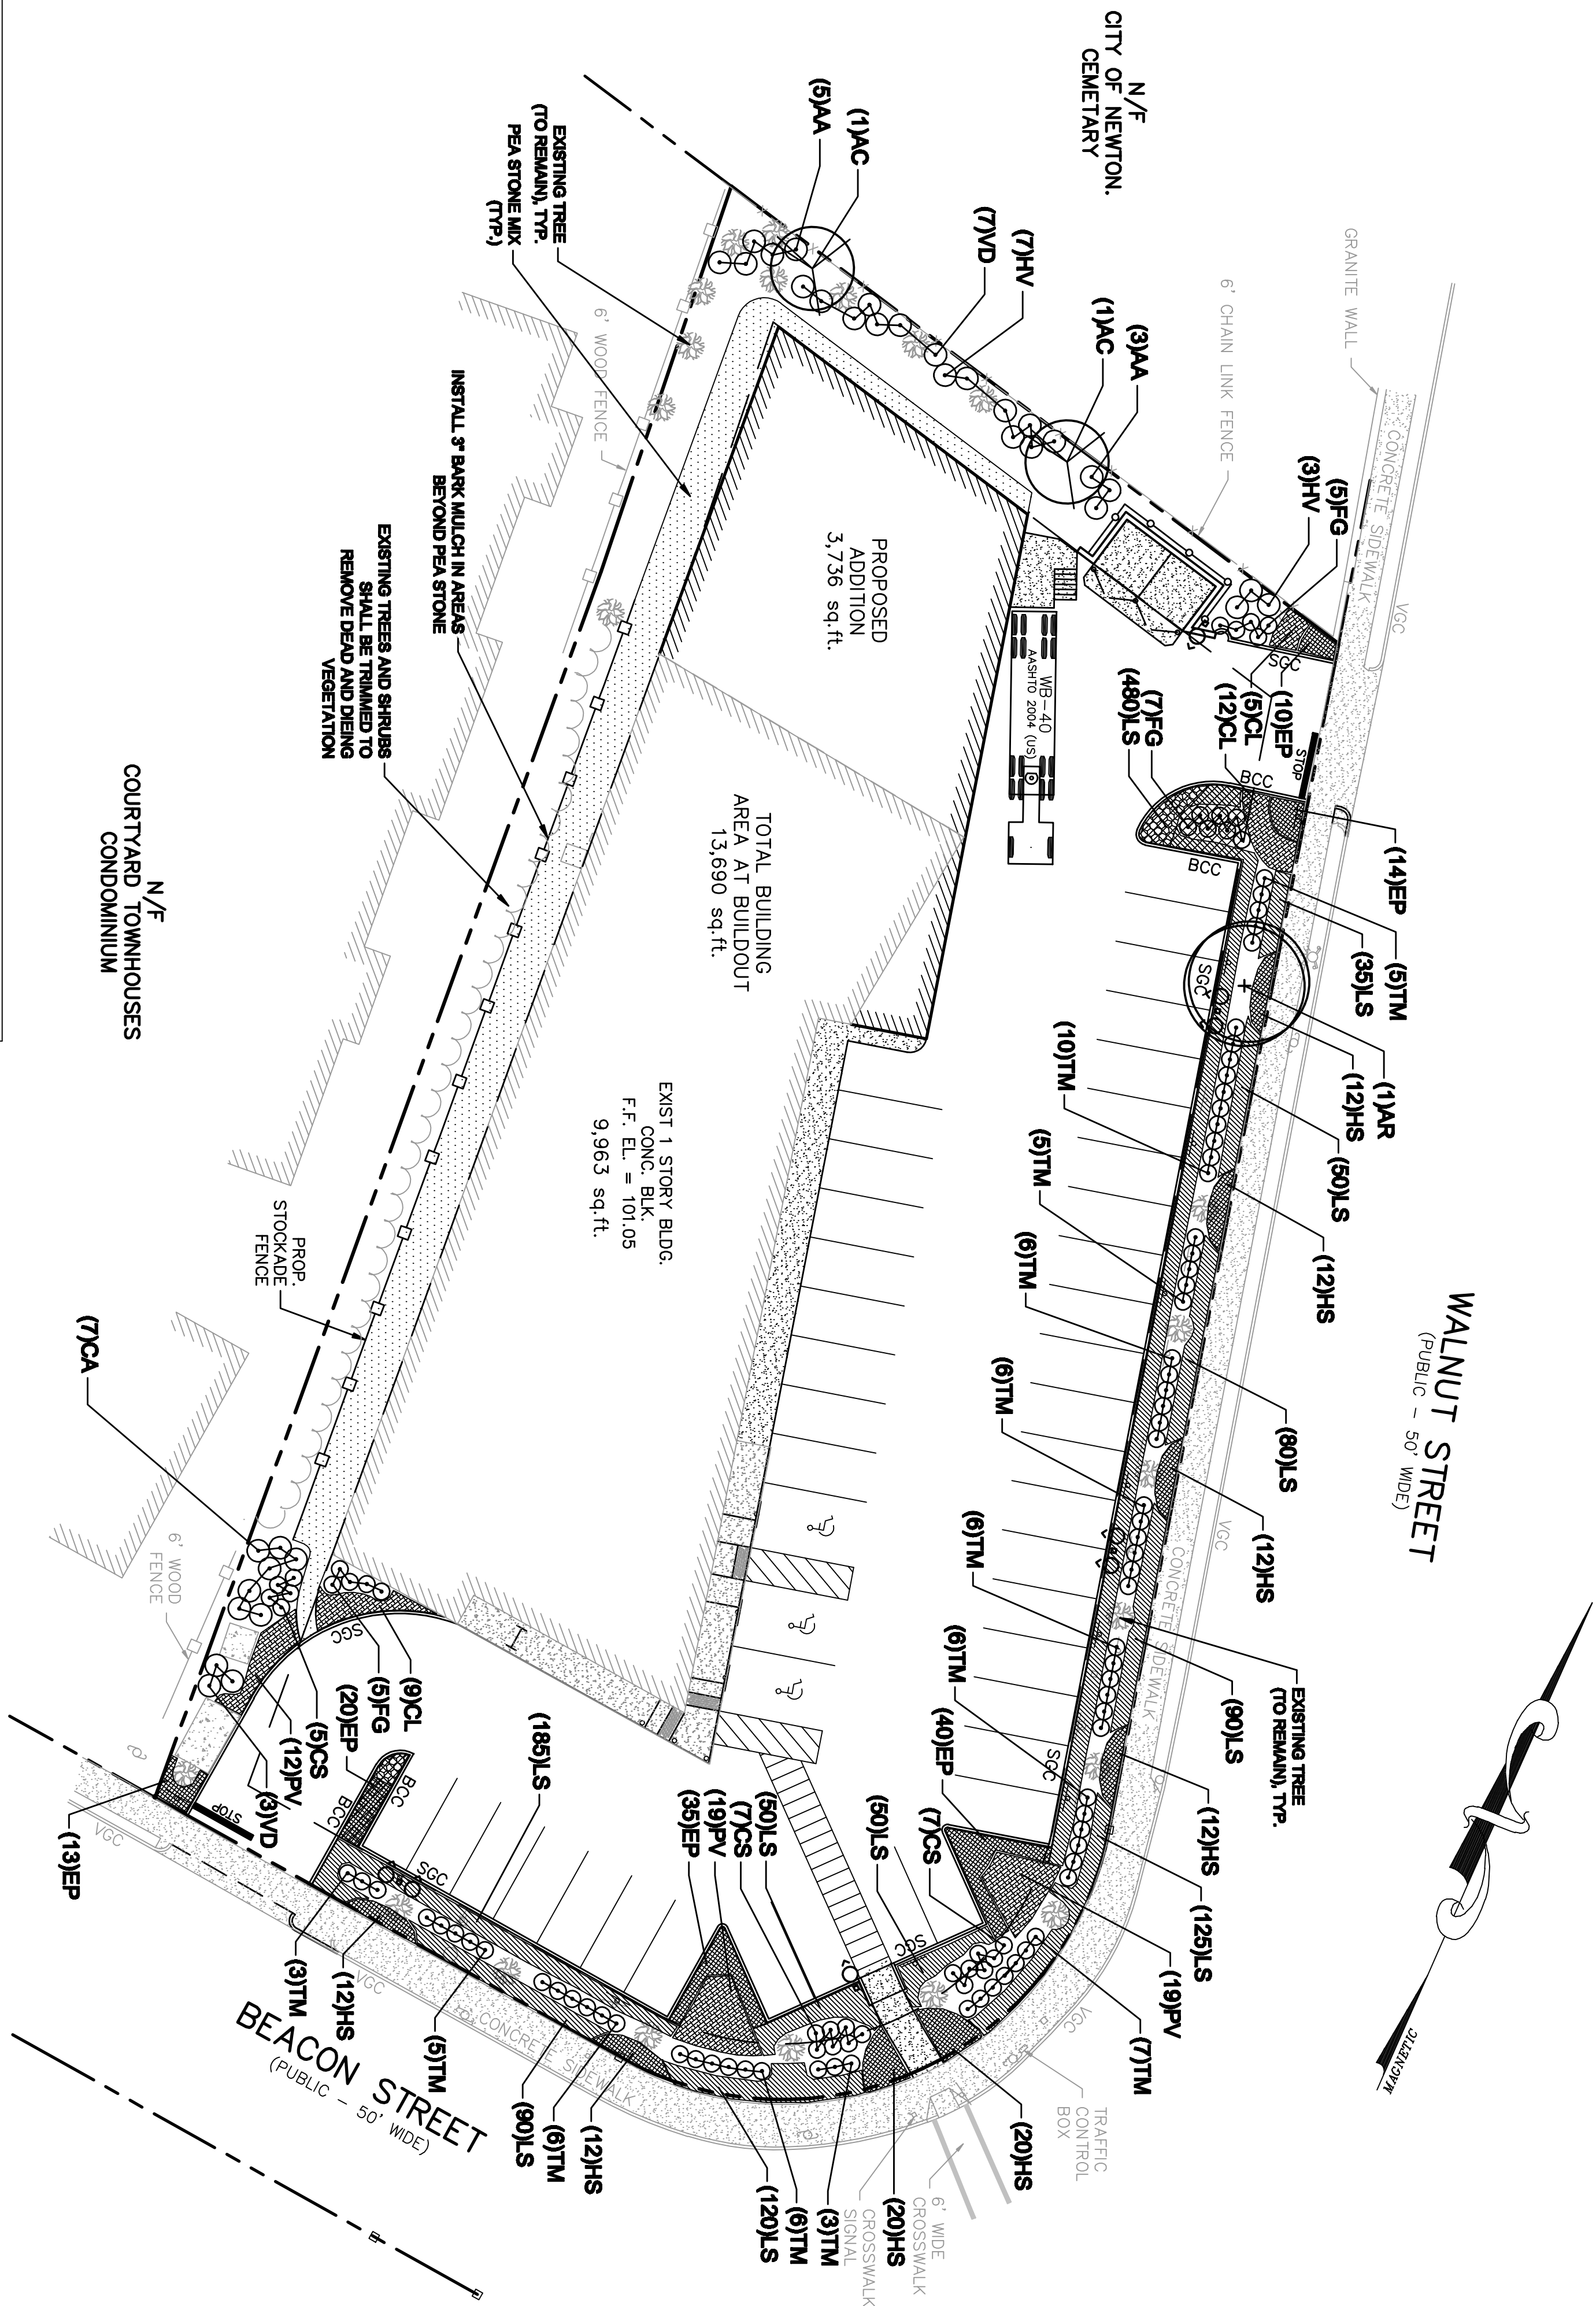

**Pennoni Associates Inc.** 100 Burt Road, Suite 120, Andover, MA 01810 Tel. (978) 749-9929, Fax. (978) 749-9920  
93 Stiles Road, Suite 201, Salem, NH 03079 Tel. (603) 226-1950, Fax. (603) 226-3235  
Engineers • Surveyors • Environmental Scientists • Petroleum Specialists

SCALE	1" = 20'
DRAWN BY	OPH
DATE	4/26/2012
APPROVED	<b>CS-2001</b>

JOB NO.	WALG 1106
SHEET	7 OF 16

ASSESSOR'S MAP 64 BLOCK 3 LOTS 10, 11 & 12  
1101 BEACON STREET  
NEWTON, MA

**LANDSCAPE AND LIGHTING PLAN**

PREPARED FOR:  
**WALGREEN'S REAL ESTATE**  
106 MILMOT ROAD  
DEERFIELD, IL 60015-5105

ALL DIMENSIONS MUST BE VERIFIED BY THE CONTRACTOR AND OWNER MUST BE NOTIFIED OF ANY DISCREPANCIES BEFORE PROCEEDING WITH THE WORK

DATE	NO.	REVISIONS	BY

