


- LEGEND**
- Area limit line
- ELECTRICAL**
- Fixture, ceiling grid, 2x2
 - Fixture, recessed
 - ▭ Fixture, fluorescent
- FIRE PROTECTION**
- ⊙ Detector, smoke
 - ⌂ Emergency light
 - ⊗ Exit sign, ceiling
 - ⊗ Exit sign, wall
 - ⚠ Fire extinguisher
 - ⌂ Horn & light
 - ⌂ Pull station
 - Sprinkler head
- MECHANICAL**
- ▭ Diffuser, return-ceiling
 - ▭ Diffuser, supply-ceiling

SECOND FLOOR AREAS

Space	Area
Office Suite 1 (net)	756.76 s.f.
Office 2 (net)	105.38 s.f.
Office 3 (net)	398.37 s.f.
Common Area (stairs, elevator, corridor, toilets)	909.68 s.f.
Total Gross Floor Area	2,170.19 s.f.



EXISTING SECOND FLOOR PLAN ②
 SCALE: 3/16" = 1'-0"

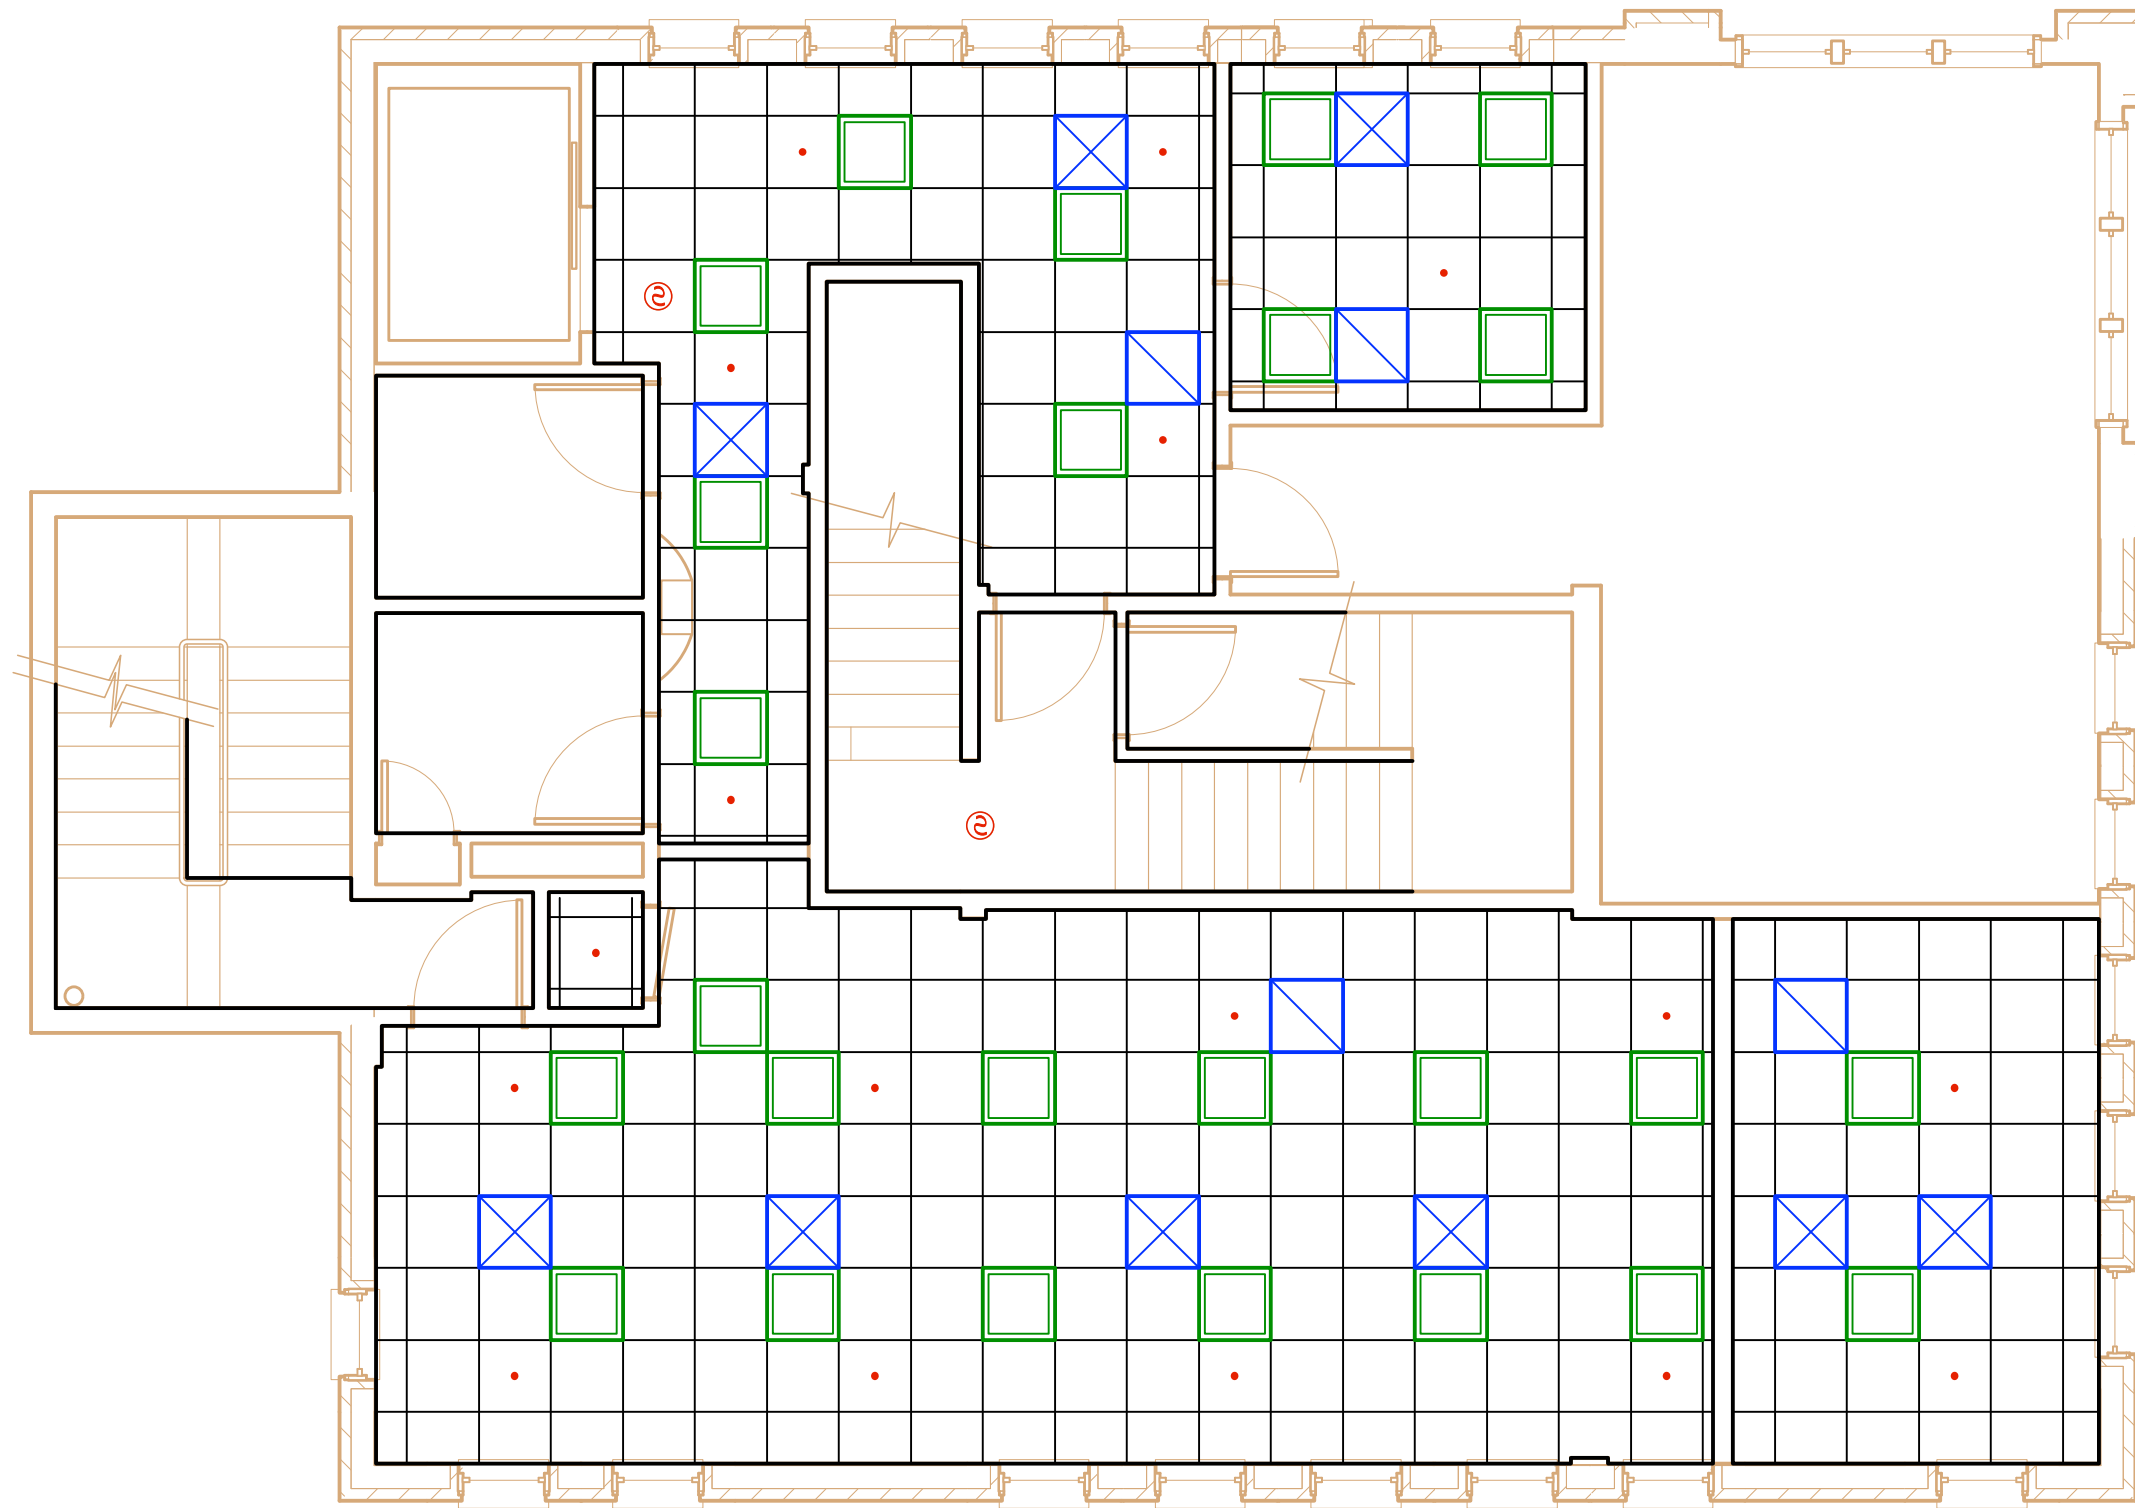

LEGEND

— Area limit line

ELECTRICAL

- Fixture, ceiling grid, 2x2
- Fixture, recessed
- Fixture, fluorescent

FIRE PROTECTION

- e Detector, smoke
- Emergency light
- X Exit sign, ceiling
- X Exit sign, wall
- ▲ Fire extinguisher
- H Horn & light
- P Pull station
- Sprinkler head

MECHANICAL

- / Diffuser, return-ceiling
- \ Diffuser, supply-ceiling



EXISTING SECOND FLOOR REFLECTED CEILING PLAN

SCALE: 3/16" = 1'-0"

2